



MISSION COLLEGE

CONSTRUCTION NOTICE



Location: Lot B + E
Subject: Solar Inverter Start-up

Dear Mission College Community,

A contractor will be servicing the solar panels in Lot B + E. A few parking stalls will be blocked in the 40 min parking lot on May 5 and 6. 12 stalls will be blocked in Lot E and 32 in Lot B on May 7. No power interruptions or shut-downs are planned.

We understand that this project may create some inconveniences. We will do our best to minimize the amount of disruption.

Thank you for your support to our Construction projects.

Anticipated Schedule

Date: May 5 - 7, 2025

Time: 7:00 am - 4:00 pm

Project Contacts:

Nini Reyes-Bolinger,
Exec. Director of Bond
Construction

District Facilities Department
Nini.Reyes-Bolinger@wvm.edu
(408) 855-5134

Jordan Salinas, WVM
Jordan.Salinas@wvm.edu
(669) 208-5426

Joseph Martinez,
Senior Project Manager
Gilbane Building Company
JMartinez@GilbaneCo.com
(408) 309-6977

Lot B Logistics Plan

Lot B - 32 Inverter Locations
Wed 5/7, 7AM-4PM, 1 stall
blocked per inverter, stalls to
be opened as each inverter is
completed

- GENERAL NOTES:
1. THE CONTRACTOR IS RESPONSIBLE FOR INVESTIGATING AND VERIFYING THE ACTUAL LOCATION AND DEPTH OF ALL EXISTING UNDERGROUND FACILITIES. PROVIDE REDLINE DRAWINGS SHOWING THE IDENTIFIED UNDERGROUND UTILITIES IN THE AS-BUILT SUBMITTAL.
 2. ANY EXISTING UTILITIES THAT ARE DAMAGED BY THE CONTRACTOR'S WORK SHALL BE REPAIRED AT CONTRACTOR'S COST WHETHER OR NOT UTILITIES ARE INDICATED ON SITE PLANS.
 3. PATCH AND REPAIR ALL SURFACES DAMAGED BY TRENCHING TO MATCH EXISTING. ANY EXISTING PARKING STRIPING THAT IS CUT BY NEW TRENCH WORK SHALL BE REPAINTED. SEE TRENCH DETAILS FOR PAVEMENT REPAIR DETAIL.
 4. TRENCH ROUTING AS SHOWN IS DIAGRAMMATIC AND CONTRACTOR MAY ADJUST TO SUIT FIELD CONDITIONS. PROVIDE SHOP DRAWINGS FOR REVIEW INDICATING ANY CHANGES TO PROPOSED ROUTING AND HANDHOLE LOCATIONS. AT UTILITY CROSSINGS ROUTE NEW TRENCHES PER DETAIL 6 ON E601.
 5. CONTRACTOR SHALL PROVIDE TRAFFIC RATED HANDHOLES FOR ALL UNDERGROUND ELECTRICAL RUNS EXCEEDING 360 DEGREES BENDS AND AS REQUIRED SO AS NOT TO EXCEED THE MANUFACTURER'S CABLE PULLING TENSION. PROVIDE HANDHOLES WHETHER OR NOT INDICATED ON DRAWINGS.
 6. EXPOSED CONDUITS ON ARRAYS BELOW 80" ABOVE GRADE SHALL BE RIGID GALVANIZED STEEL.
 7. SEE E900 FOR COMMUNICATIONS CIRCUIT DETAILS
 8. SEE E1200 FOR LIGHTING CIRCUIT DETAILS

DSA STAMP

SUNPOWER™
1414 Harbour Way South
Richmond, CA 94804 USA
(510) 540-0550

REVAMP
ENGINEERING, INC.
555 12th St., Floor 5
Oakland, CA 94607
www.revamp-eng.com

PROFESSIONAL ENGINEER
STATE OF CALIFORNIA
E22713
ELECTRICAL


WEST VALLEY MISSION COMMUNITY COLLEGE DISTRICT
MISSION COLLEGE
3000 MISSION COLLEGE BLVD
SANTA CLARA, CA 95054
SITE LAYOUT LOT B

No.	Date	By	Rev	Description
1	3/03/2021	BB	SV	ISSUE FOR PERMIT

OPPORTUNITY 0001466321
PROJECT 12025
DATE 11/5/2020
DRAWN BY BBB

0" 1" 2"
ORIGINAL SHEET SIZE 30" x 42"
IF BAR IS NOT TO SCALE - DRAWING IS NOT TO SCALE

SHEET
E103
COPYRIGHT 2020 © SUNPOWER CORP

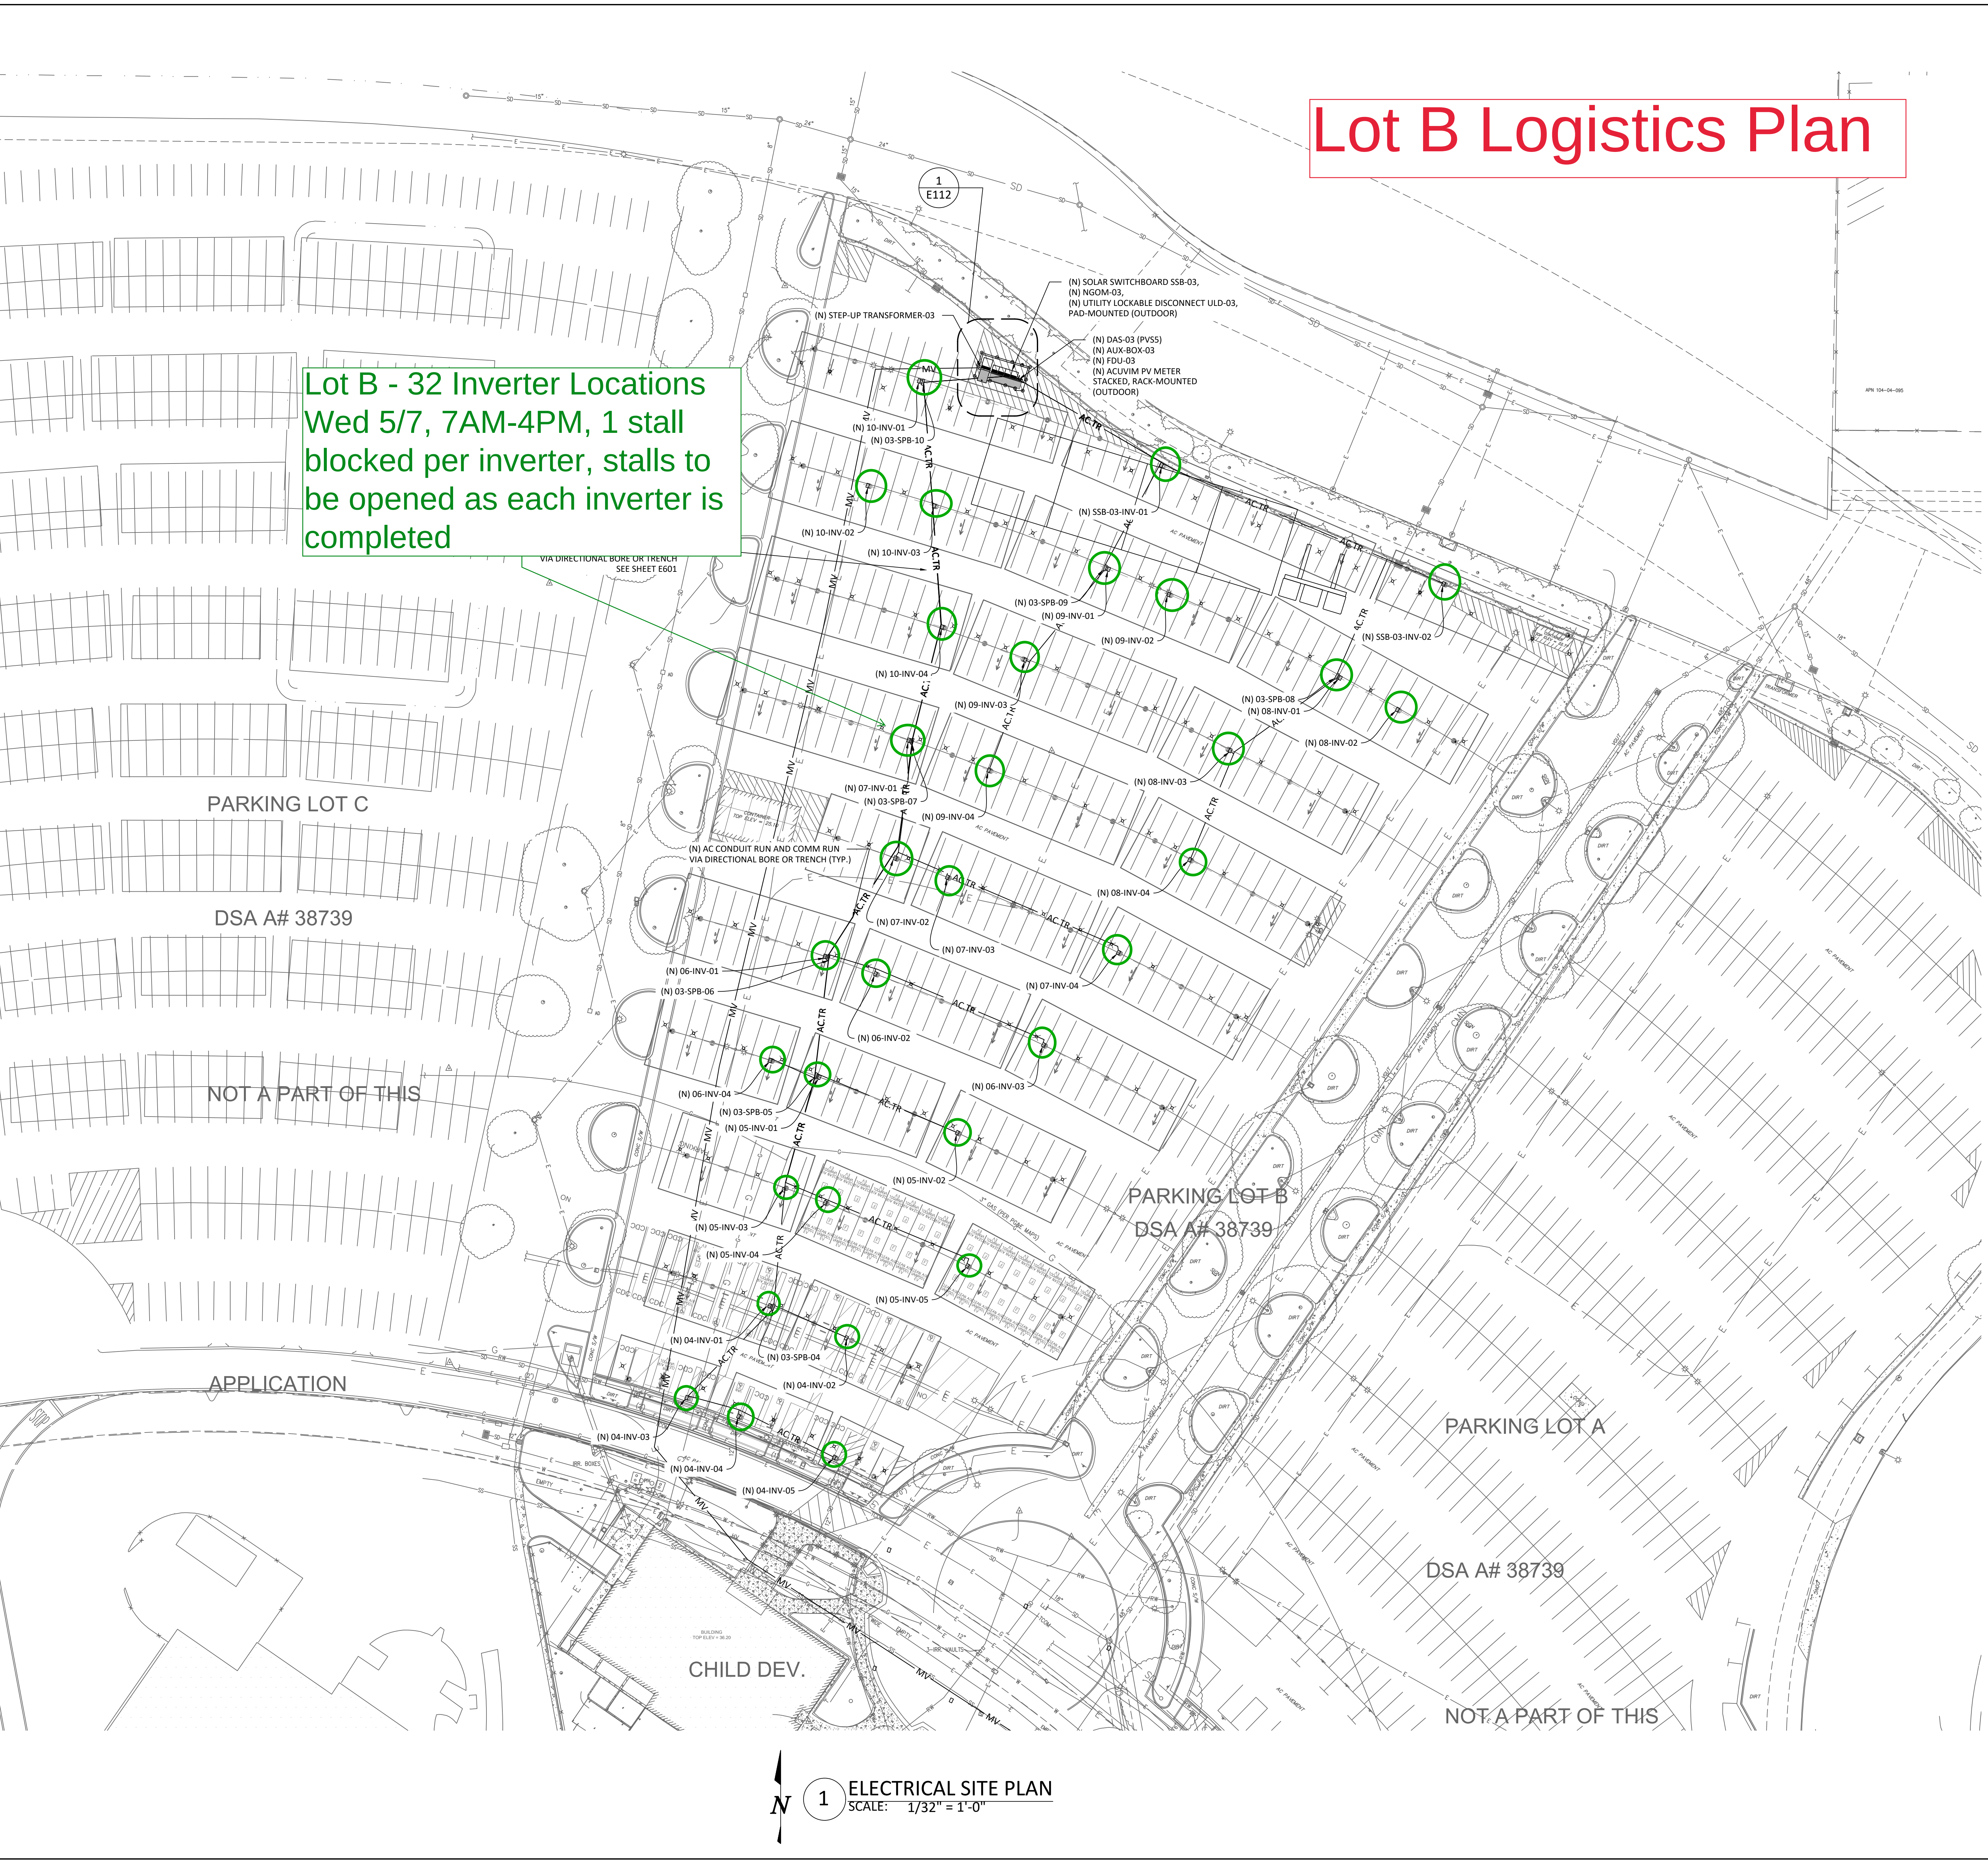

1 ELECTRICAL SITE PLAN
SCALE: 1/32" = 1'-0"

CANOPY SUPPORT HORIZONTAL CONTROL TABLE		
Point #	Northing	Easting
1	1,968,114.3	6,131,634.2
2	1,968,113.0	6,131,639.2
3	1,968,145.5	6,131,655.9
4	1,968,161.4	6,131,672.7
5	1,968,185.1	6,131,689.2
6	1,968,205.0	6,131,708.8
7	1,968,231.4	6,131,725.5
8	1,968,253.0	6,131,737.7
9	1,968,281.8	6,131,748.8
10	1,968,074.6	6,131,670.1
11	1,968,088.4	6,131,685.8
12	1,968,109.1	6,131,709.2
13	1,968,124.8	6,131,724.4
14	1,968,140.9	6,131,737.6
15	1,968,164.9	6,131,757.6
16	1,968,184.3	6,131,771.2
17	1,968,211.2	6,131,787.2
18	1,968,233.2	6,131,798.4

CANOPY SUPPORT HORIZONTAL CONTROL TABLE		
Point #	Northing	Easting
19	1,968,261.9	6,131,810.7
20	1,968,031.4	6,131,725.7
21	1,968,045.0	6,131,741.4
22	1,968,065.5	6,131,765.0
23	1,968,080.3	6,131,780.3
24	1,968,095.6	6,131,794.4
25	1,968,118.6	6,131,815.6
26	1,968,138.0	6,131,829.2
27	1,968,156.3	6,131,839.2
28	1,968,183.8	6,131,854.2
29	1,968,205.4	6,131,864.7
30	1,968,234.5	6,131,876.0
31	1,968,309.2	6,131,953.4
32	1,968,329.4	6,131,958.3
33	1,968,363.2	6,131,966.5
34	1,968,397.0	6,131,974.7
35	1,968,427.3	6,131,982.1


SITE CONTROL POINTS TABLE		
Control Point ID	Northing	Easting
CTRL-1	1,968,244.1	6,131,915.6
CTRL-2	1,968,297.1	6,131,793.8
CTRL-3	1,968,121.2	6,131,660.5
CTRL-4	1,968,403.2	6,131,998.9

NOTES:

- COORDINATES SHOWN REFERENCE THE NAD83 CALIFORNIA STATE PLANE COORDINATE SYSTEM (ZONE III).
- CONTRACTOR SHALL VERIFY ALL CONTROL POINT LOCATIONS IN FIELD PRIOR TO CONSTRUCTION. CONTRACTOR SHALL USE CONTROL POINTS AS REFERENCE FOR COLUMN LOCATIONS.

Lot E Logistics Plan

Lot E - 12 Inverter Locations
Wed 5/7, 7-9AM, 1 stall blocked per inverter, stalls to be opened as each inverter is completed

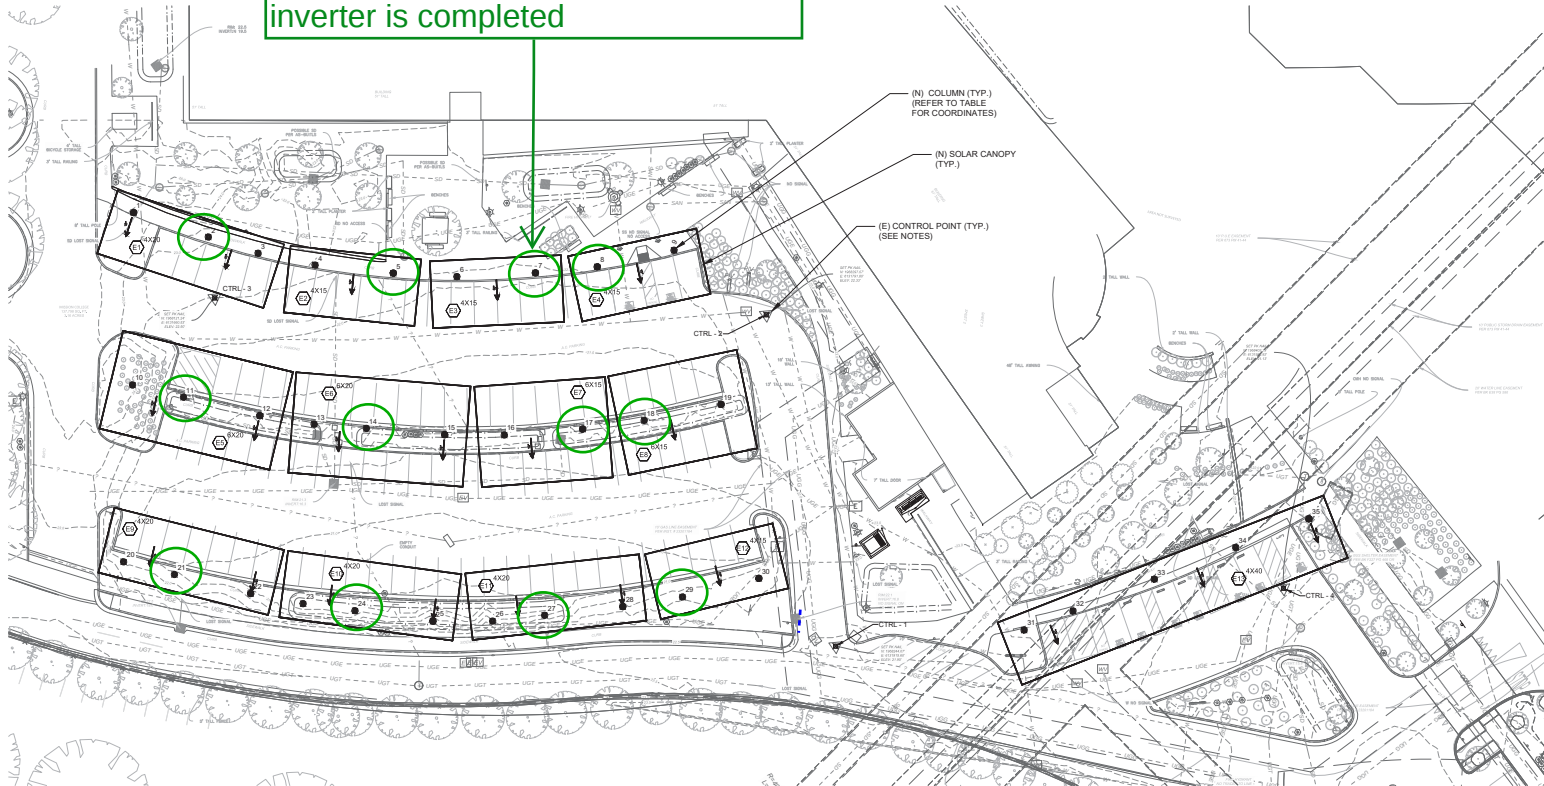

SCALE: 1" = 20'

DEA STAMP

SUNPOWER™
1414 Harbour Way South
Richmond, CA 94804 USA
(510) 540-0550

Dewberry
Dewberry
Engineers Inc.



WEST VALLEY MISSION COMMUNITY COLLEGE DISTRICT
MISSION COLLEGE
3900 MISSION COLLEGE BLVD
SANTA CLARA, CA 95054

HORIZONTAL CONTROL PLAN - LOT E

REVISION SCHEDULE	
NO.	DESCRIPTION
1	ISSUED FOR PERMIT
2	ISSUED FOR PERMIT
3	ISSUED FOR PERMIT
4	ISSUED FOR PERMIT
5	ISSUED FOR PERMIT
6	ISSUED FOR PERMIT
7	ISSUED FOR PERMIT
8	ISSUED FOR PERMIT
9	ISSUED FOR PERMIT
10	ISSUED FOR PERMIT
11	ISSUED FOR PERMIT
12	ISSUED FOR PERMIT
13	ISSUED FOR PERMIT
14	ISSUED FOR PERMIT
15	ISSUED FOR PERMIT
16	ISSUED FOR PERMIT
17	ISSUED FOR PERMIT
18	ISSUED FOR PERMIT
19	ISSUED FOR PERMIT
20	ISSUED FOR PERMIT

OPPORTUNITY #
PROJECT #
DATE 11/18/20
DRAWN BY SJA



SHEET
C400
COPYRIGHT 2020 BY SUNPOWER CORP.